


1 Roof Plan As Proposed
SCALE - 1:100 @ A1 - 1:200 @ A3

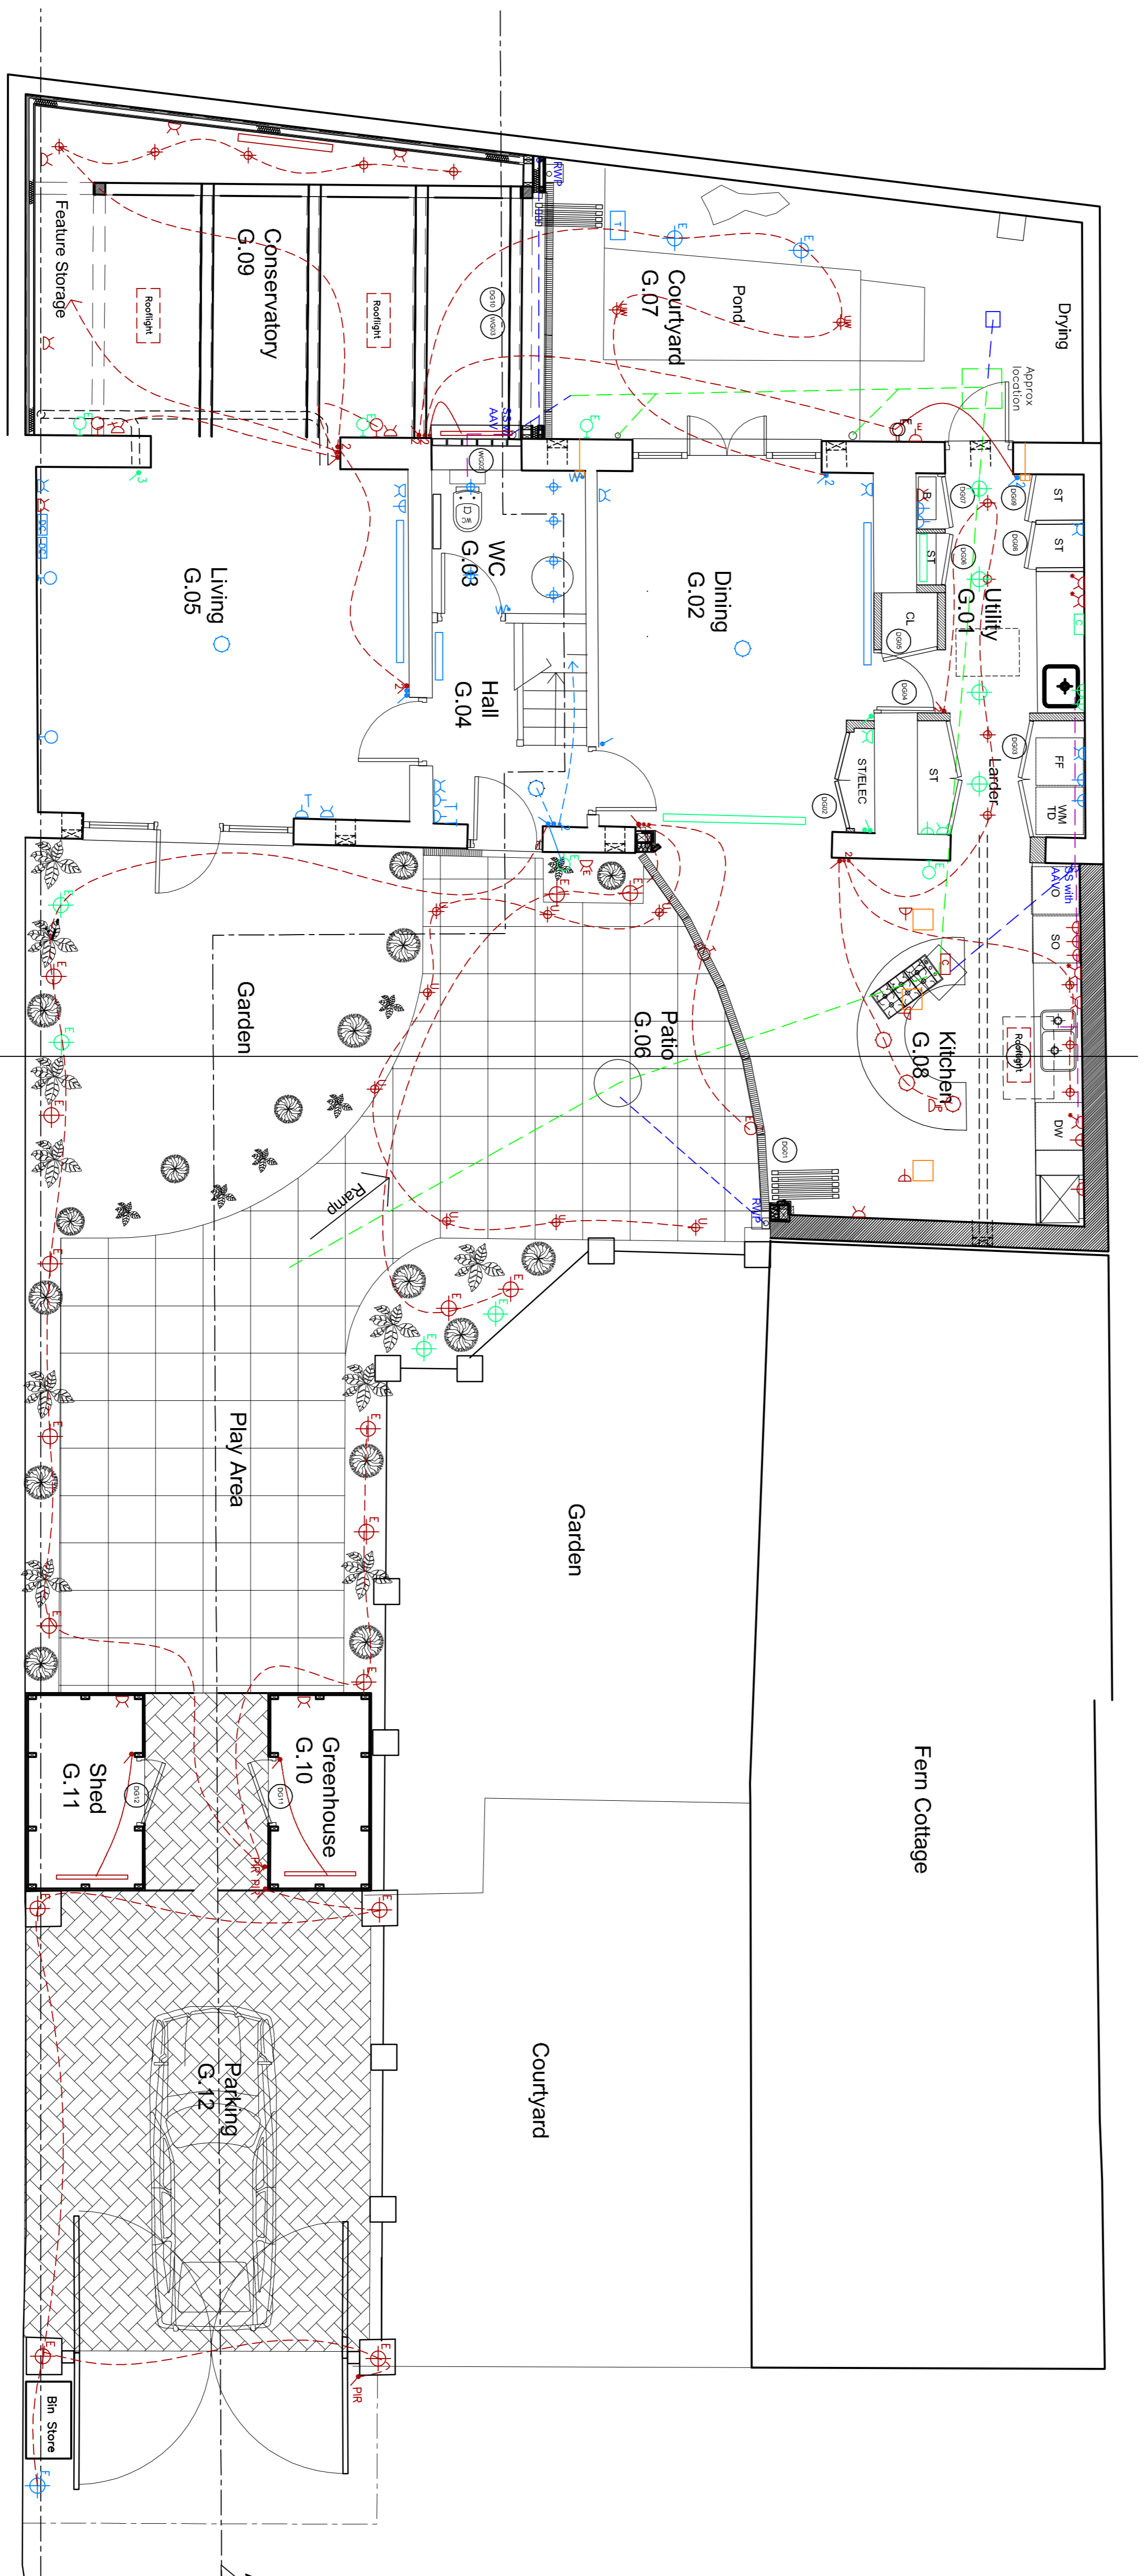

1 Ground Floor Plan As Proposed
SCALE - 1:50 @ A1 - 1:100 @ A3



1. This drawing has been based upon a survey that was itself based on OUTLINE measurements NOT a full measured survey. As a result, considerable attention to the dimensions of any proposed works must be applied, taking site dimensions and templates as necessary.
2. While this drawing can be used as a base drawing for construction purposes, it is VERY IMPORTANT that all dimensions are checked carefully before any work commences, or any materials are ordered.
3. This drawing can be used as part of a planning application, although your planning officer may ask for more specific information about some aspects of the design. For further information ask your architect.

4. Where applicable, a suitable Structural Engineer and/or a Party Wall Surveyor should be consulted. Although as far as possible these instances have been indicated, this is not necessarily exhaustive and the whole scope of proposed works should be reviewed.
5. Unless other arrangements have been specifically made, your building contractor should serve a Building Notice, as and where applicable, to your local authority to satisfy the requirements of the Building Regulations. Your building contractor should also liaise with the Building Control Officer regarding routine inspections of the work.

This is a 'Detail Level Drawing' and can be used as a basis for construction.
It is important to discuss all stages of your project with your architect and builder together, to ensure the appropriate level of detail is provided, see: Section G of the Services Manu.
Nonetheless, all dimensions must be checked on site and templates formed as appropriate to ensure that any manufactured item is correct for its application.


All dimensions are in millimetres
All dimensions to be checked on site
© Architect Your Home

3 KEY
SCALE - NTS

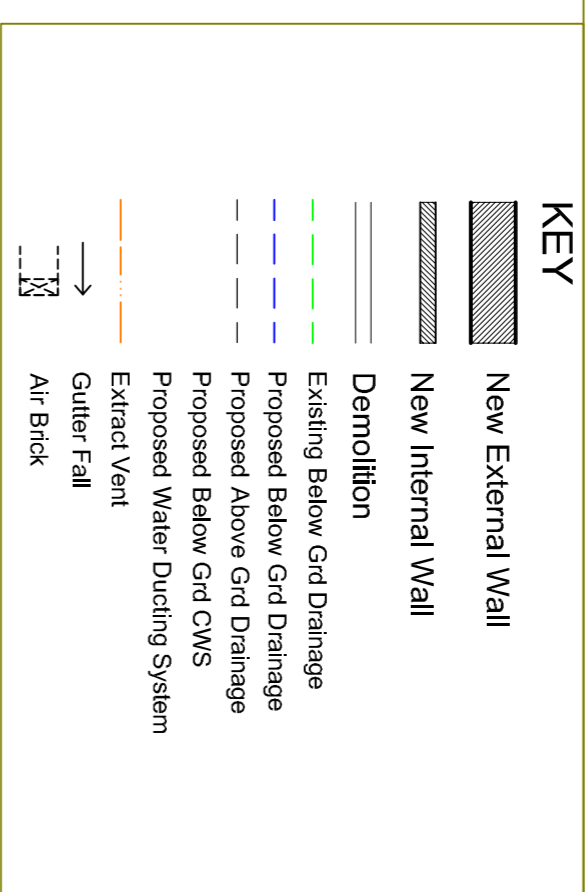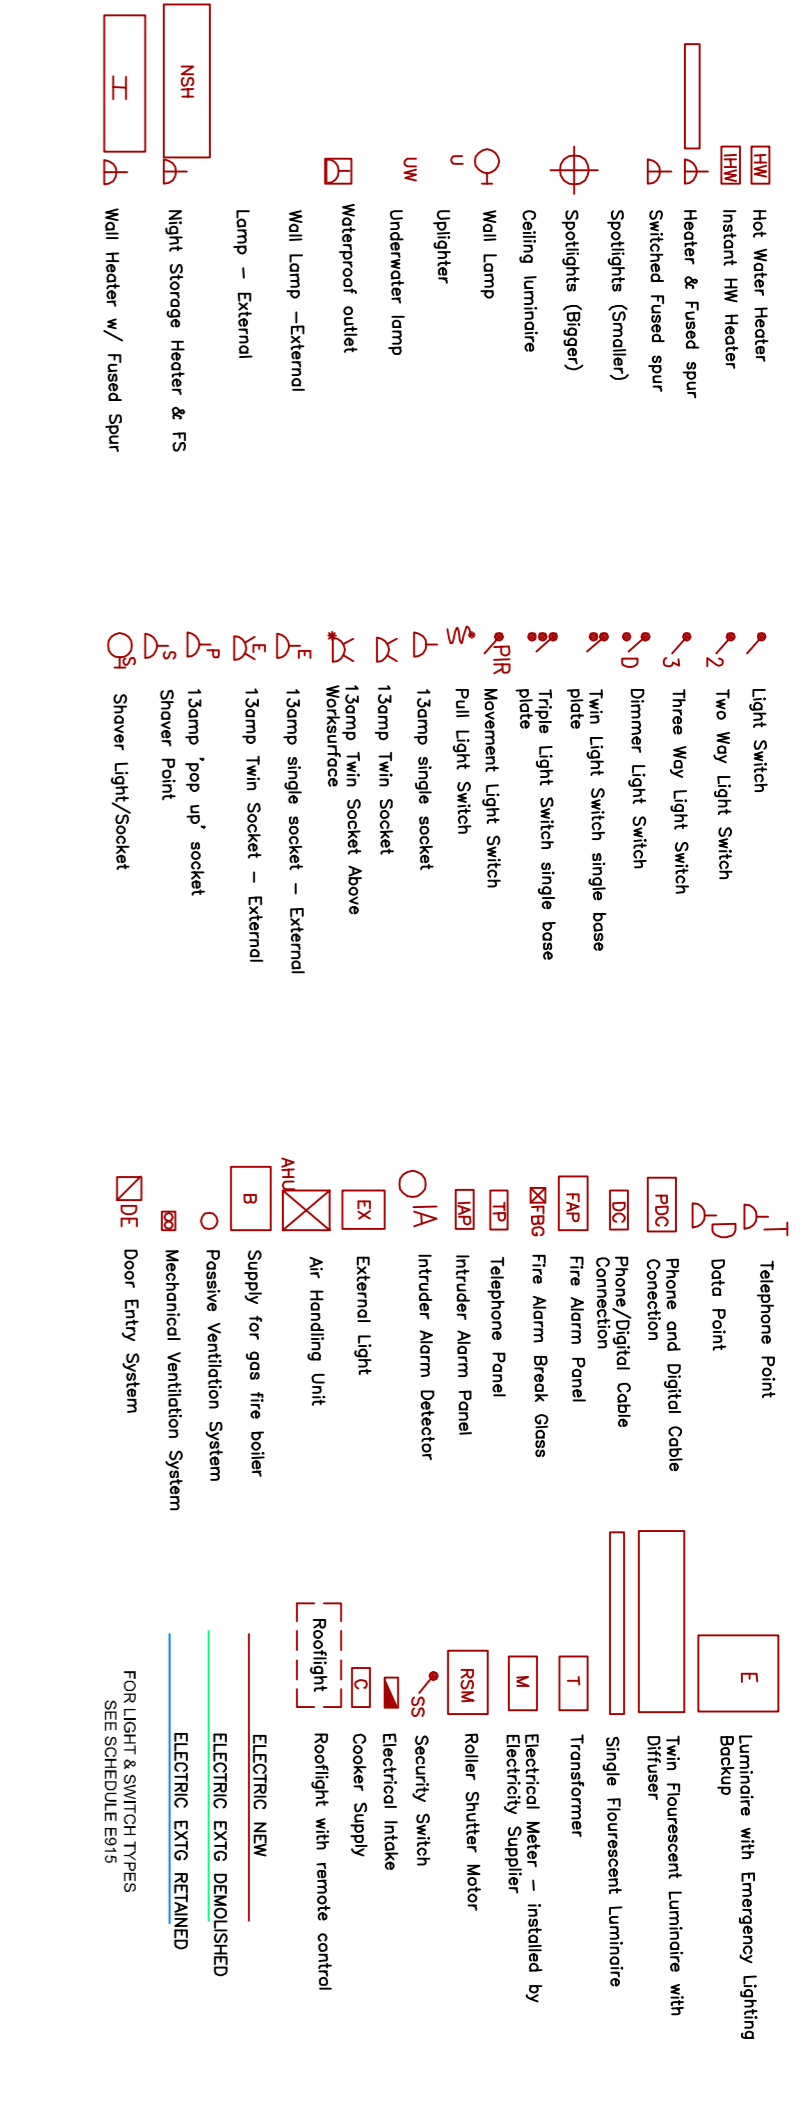

TENDER ISSUE

from an outline survey

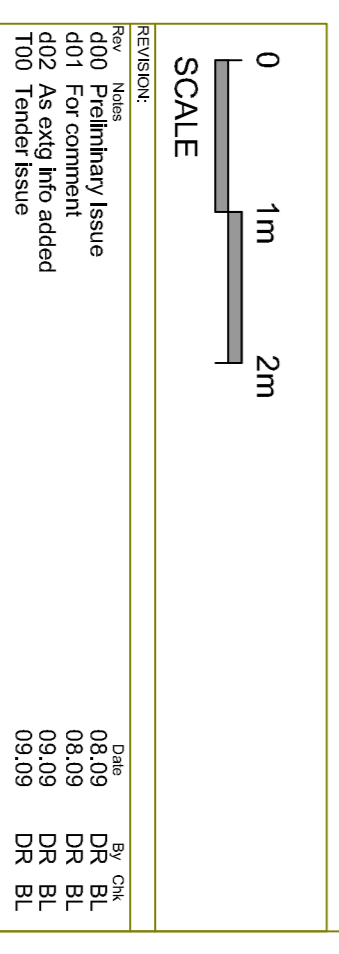

Electrical Layout - Grd Fir As Proposed

DATE: 11.10.09
JOB NUMBER: A Job No. E300
REVISION: T00
DRAWN BY: QL

Your Architect Your Home Licensee:
Architect Your Home Thames
Unit 102, 24-28 Hutton Wall
London EC1N 8JH
Tel: 020 7405 9020
Fax: 020 7405 0809
Email: thames@architect-yourhome.com

Project name:
Mr & Mrs Sample
Sample St, Sampletown

